
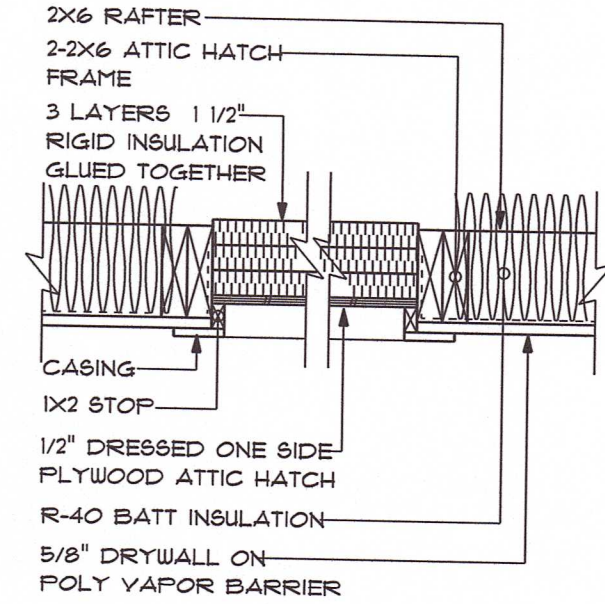


ELECTRICAL LEGEND

ELECTRICAL	COUNT	SYMBOL
co detector	6	⊙
outlet gfi	17	⊕
smoke detector	6	⊙

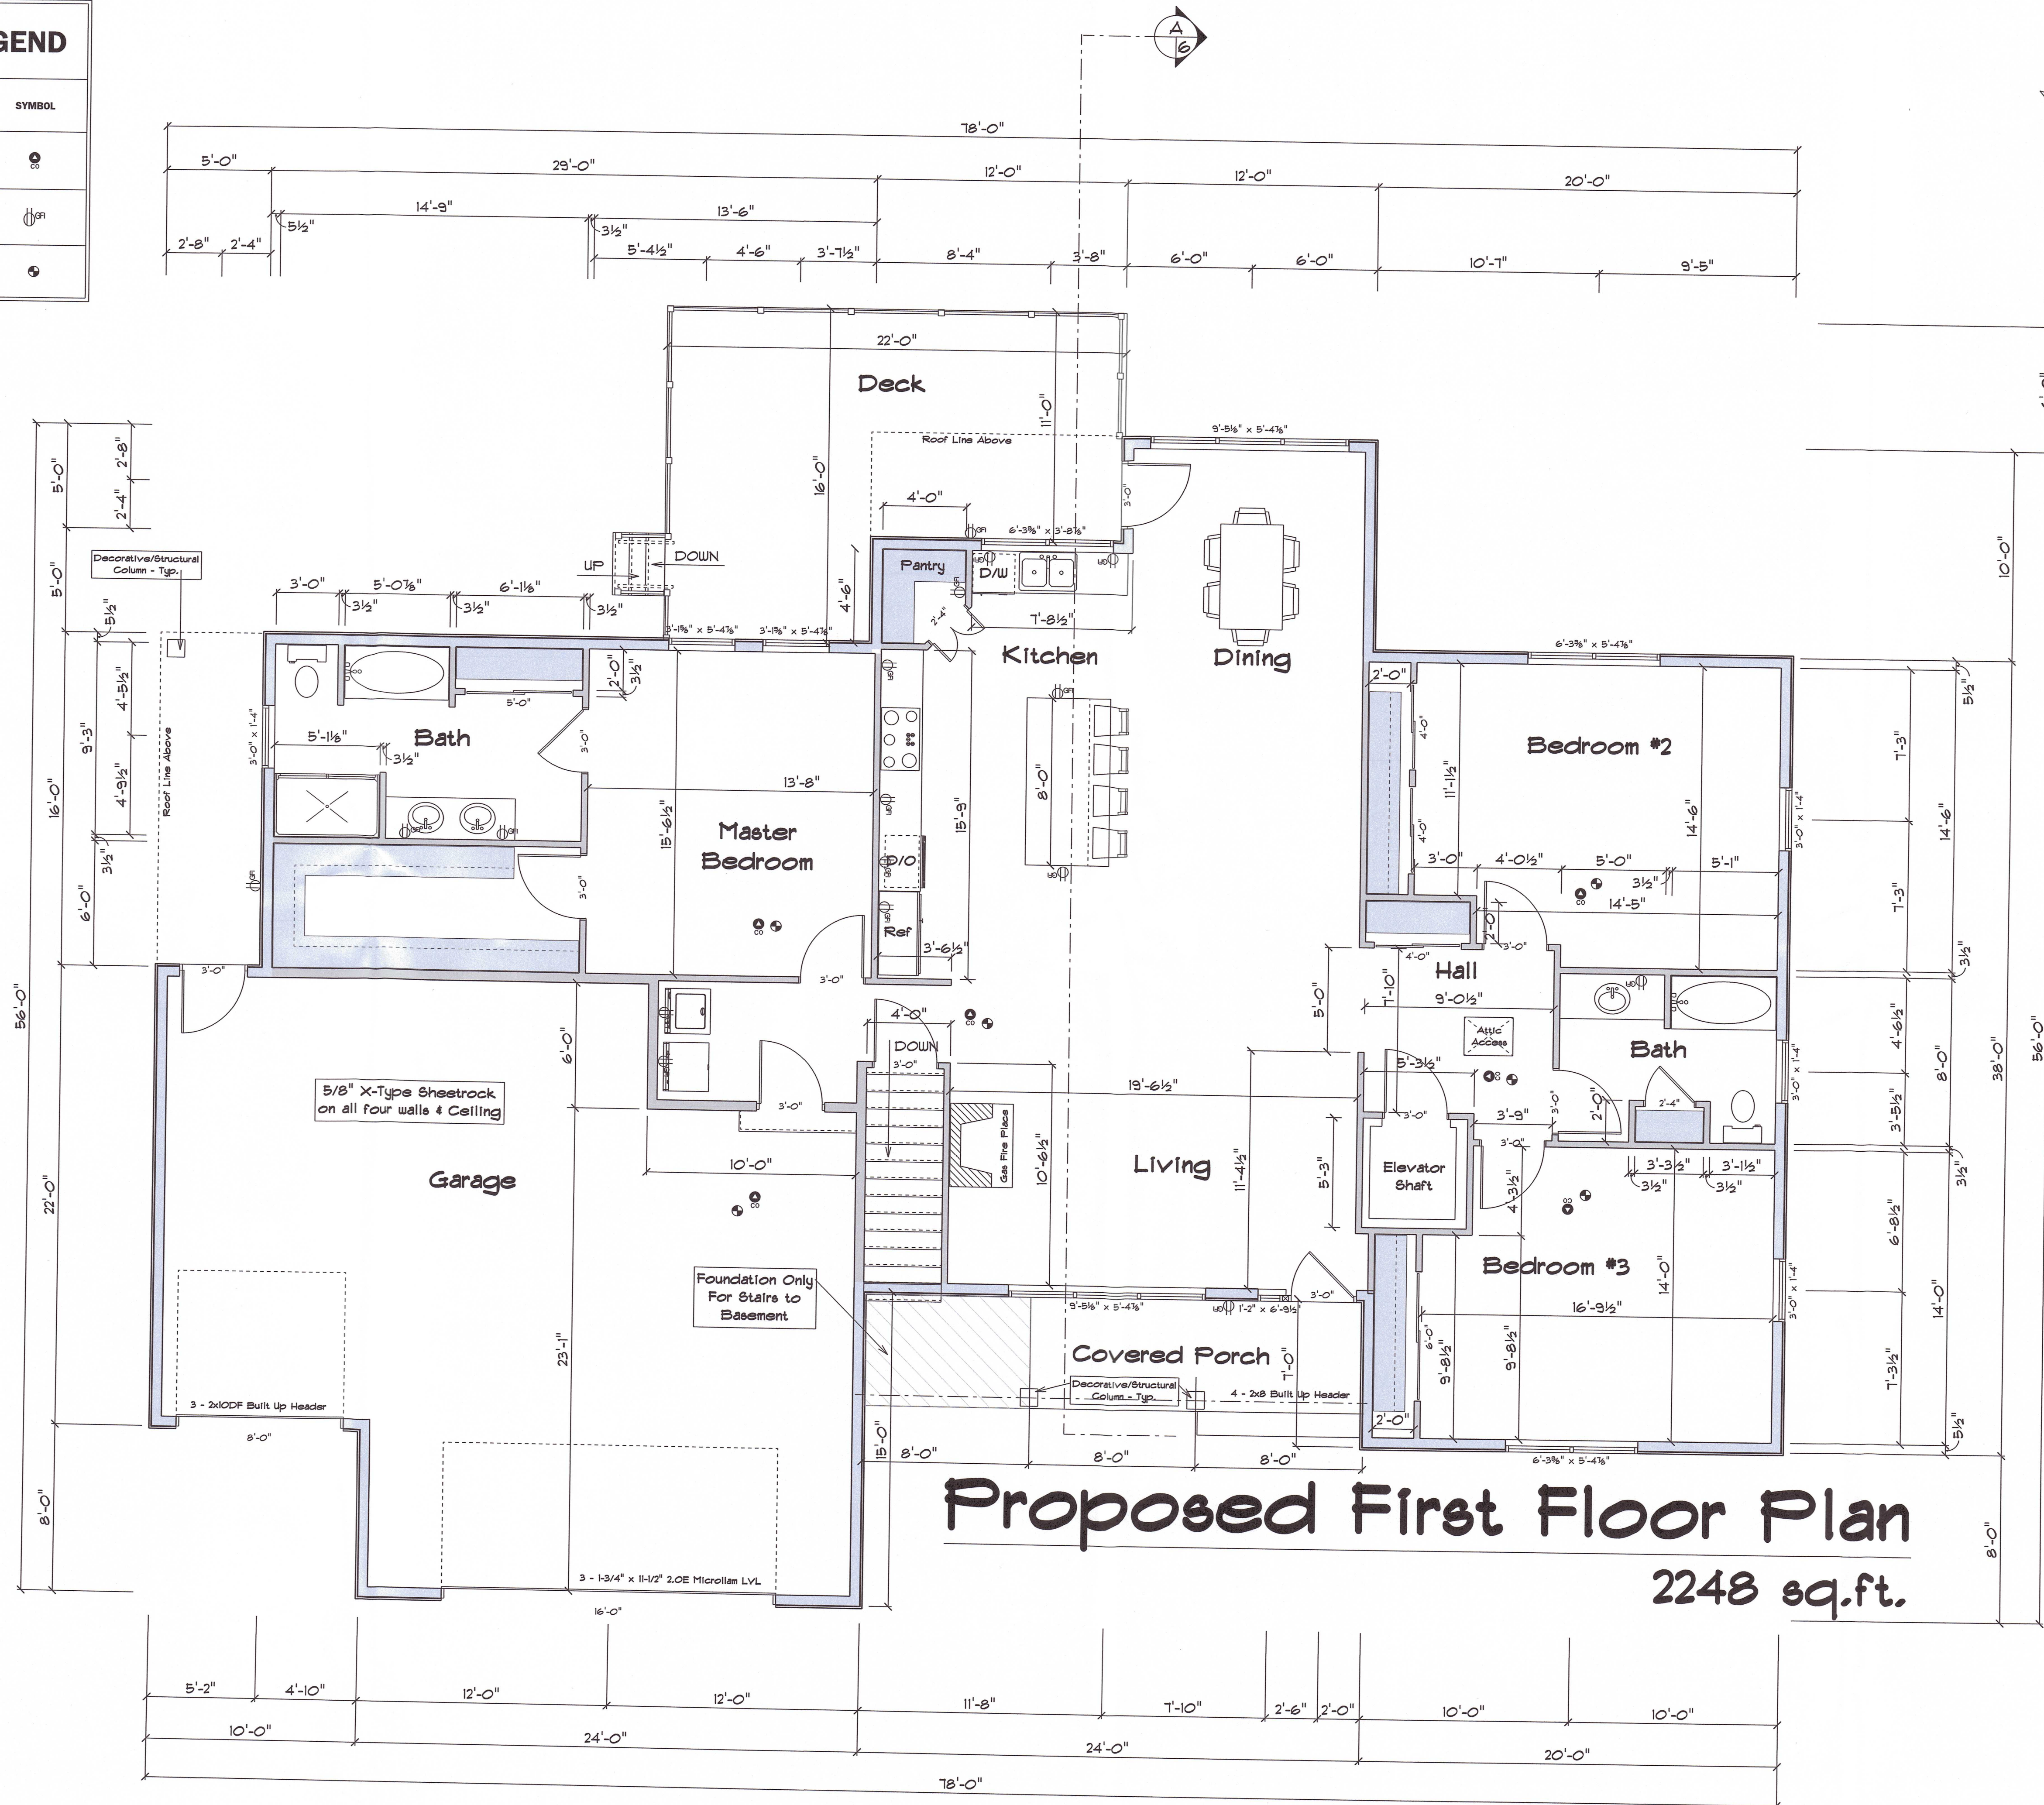

Revision	By

THIS STAMP IS INVALID
 ALL INFORMATION CONTAINED HEREIN IS UNLAWFUL TO REPRODUCE OR TRANSMIT IN ANY FORM OR BY ANY MEANS, ELECTRONIC OR MECHANICAL, INCLUDING PHOTOCOPYING, RECORDING, OR BY ANY INFORMATION STORAGE AND RETRIEVAL SYSTEM. WITHOUT THE WRITTEN PERMISSION OF THE ARCHITECT. THE ARCHITECT ASSUMES NO RESPONSIBILITY FOR ANY DAMAGES INCLUDING STRUCTURAL FAILURE, DUE TO ANY DEFICIENCIES OR OMISSIONS IN THE DESIGN OR BLUEPRINTS. IT IS RECOMMENDED THAT YOU CONSULT A LOCAL ARCHITECT PRIOR TO THE START OF ACTUAL CONSTRUCTION.

May 12, 2022
 Scale = 1/4" = 1'-0"
 Drawn By BPH
 Page 5 of 1

Proposed First Floor Plan
 Huhn
 32 Village Dr
 Ledyard, CT 06339

75 Lebanon Ave
 Colchester, CT 06415
 860-885-6189
 860-603-2622 fax



Bruce P. Hahn aka "Bruno" 2015